



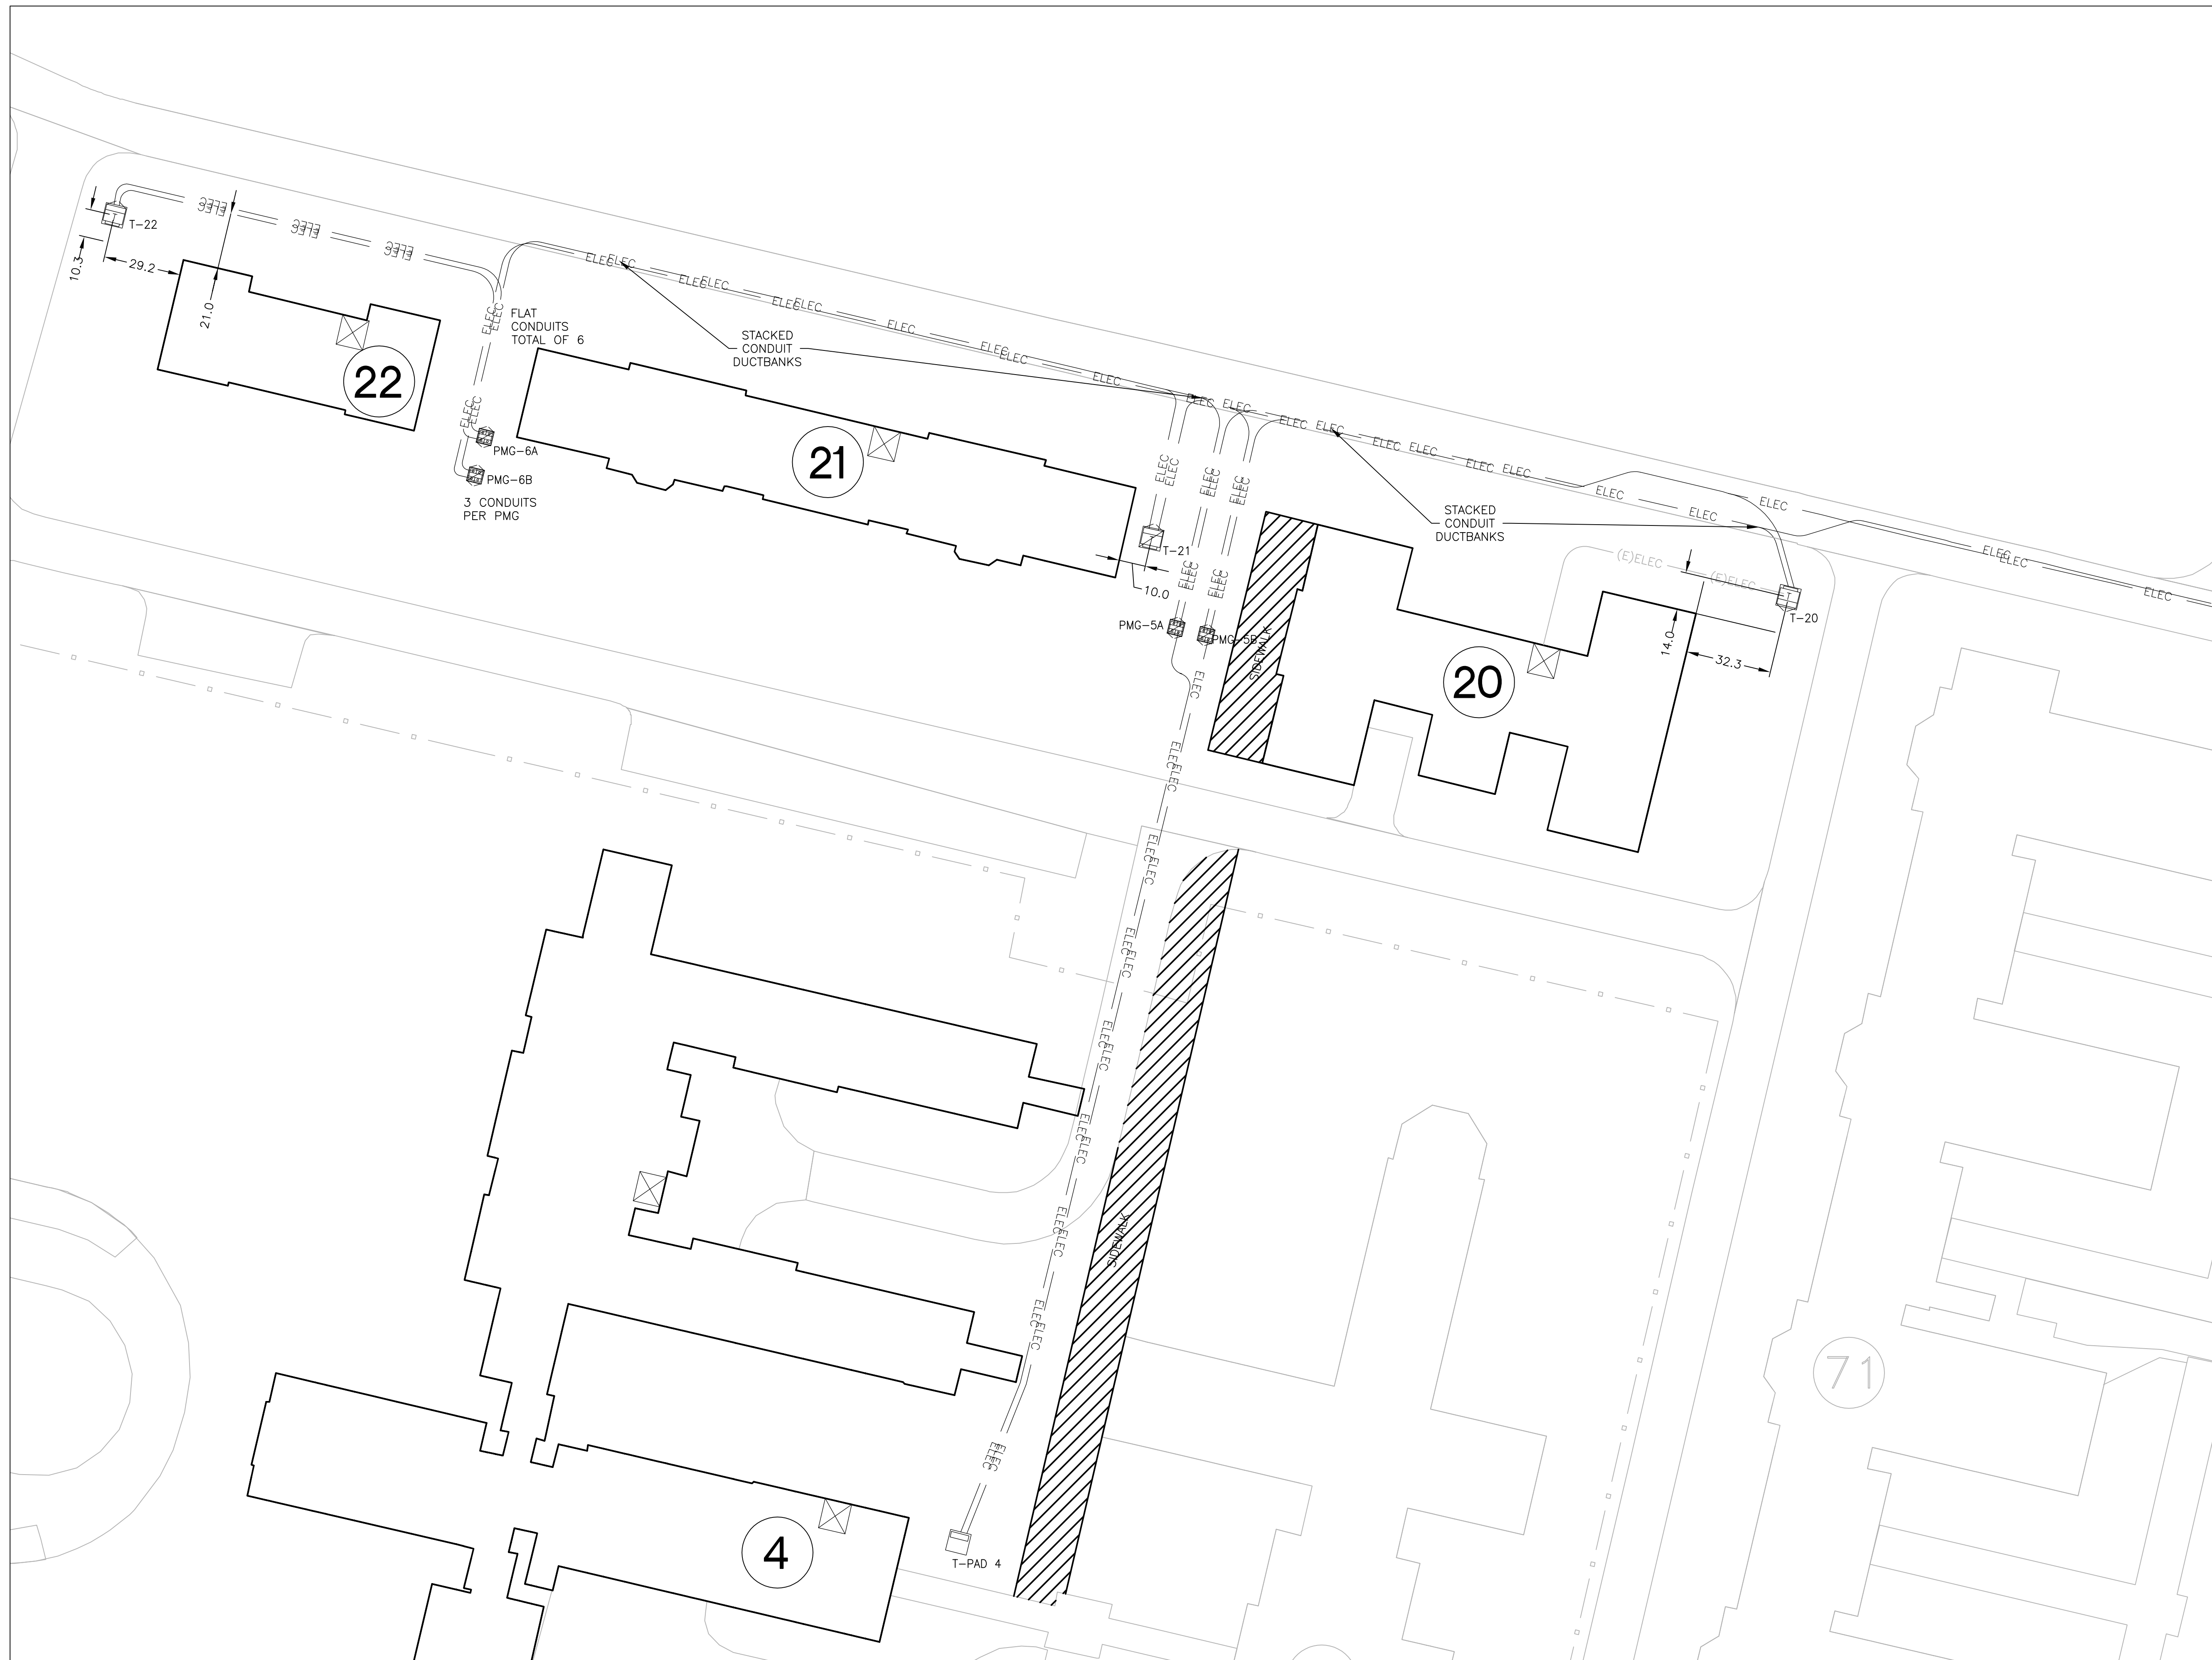


NOTES:

1. TYPICAL DEPTH OF DUCT BANK IS 42" A.F.G.
2. NO UTILITIES WERE ENCOUNTERED DURING EXCAVATION UNLESS OTHERWISE NOTED.

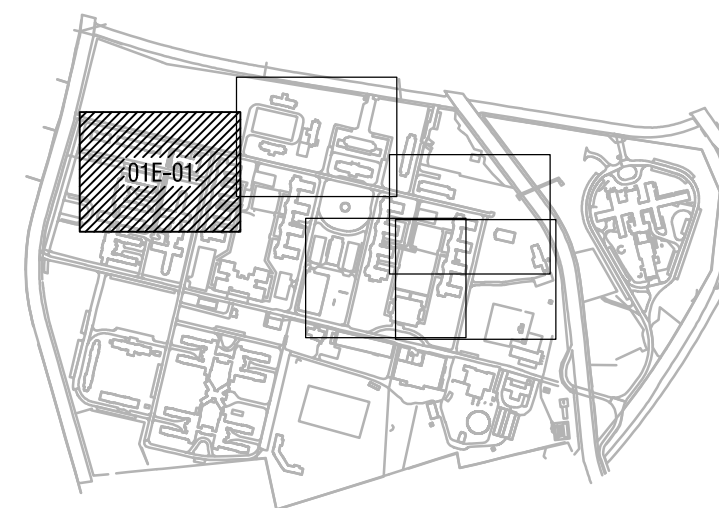

MATCH LINE - SEE SHEET 01E-02

PROJECT RECORD
AS BUILT

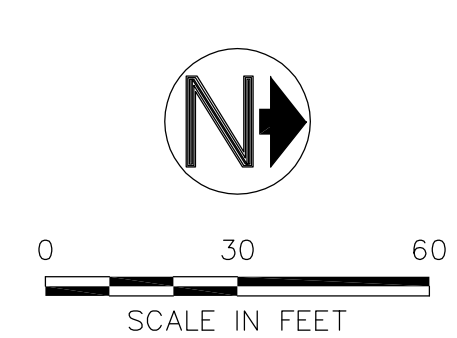

NEW YORK STATE
DEPARTMENT OF MENTAL HEALTH
CREEDMOOR PSYCHIATRIC CENTER
80-45 WINCHESTER BLVD
QUEENS, N.Y. 11427

ELECTRICAL SITE PLAN


01E-01

SCALE	1" = 30'
FILENAME	01E-01.dwg




NOTES:

1. TYPICAL DEPTH OF DUCT BANK IS 42" A.F.G.
2. NO UTILITIES WERE ENCOUNTERED DURING EXCAVATION UNLESS OTHERWISE NOTED.

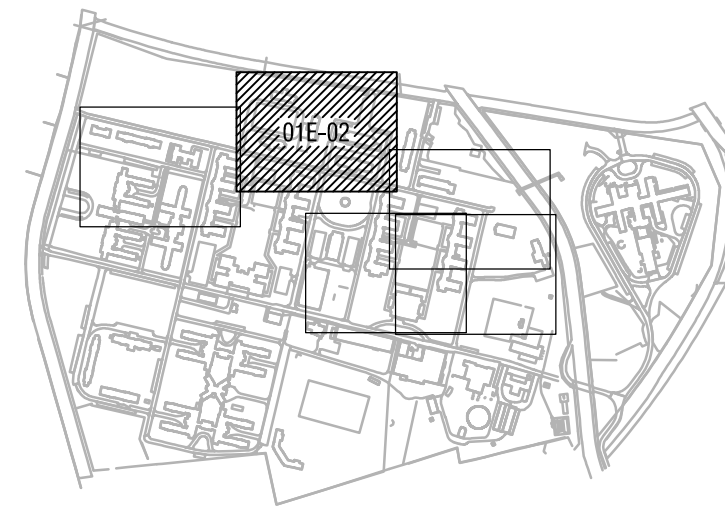


MATCH LINE - SEE SHEET 01E-01

MATCH LINE - SEE SHEET 01E-03

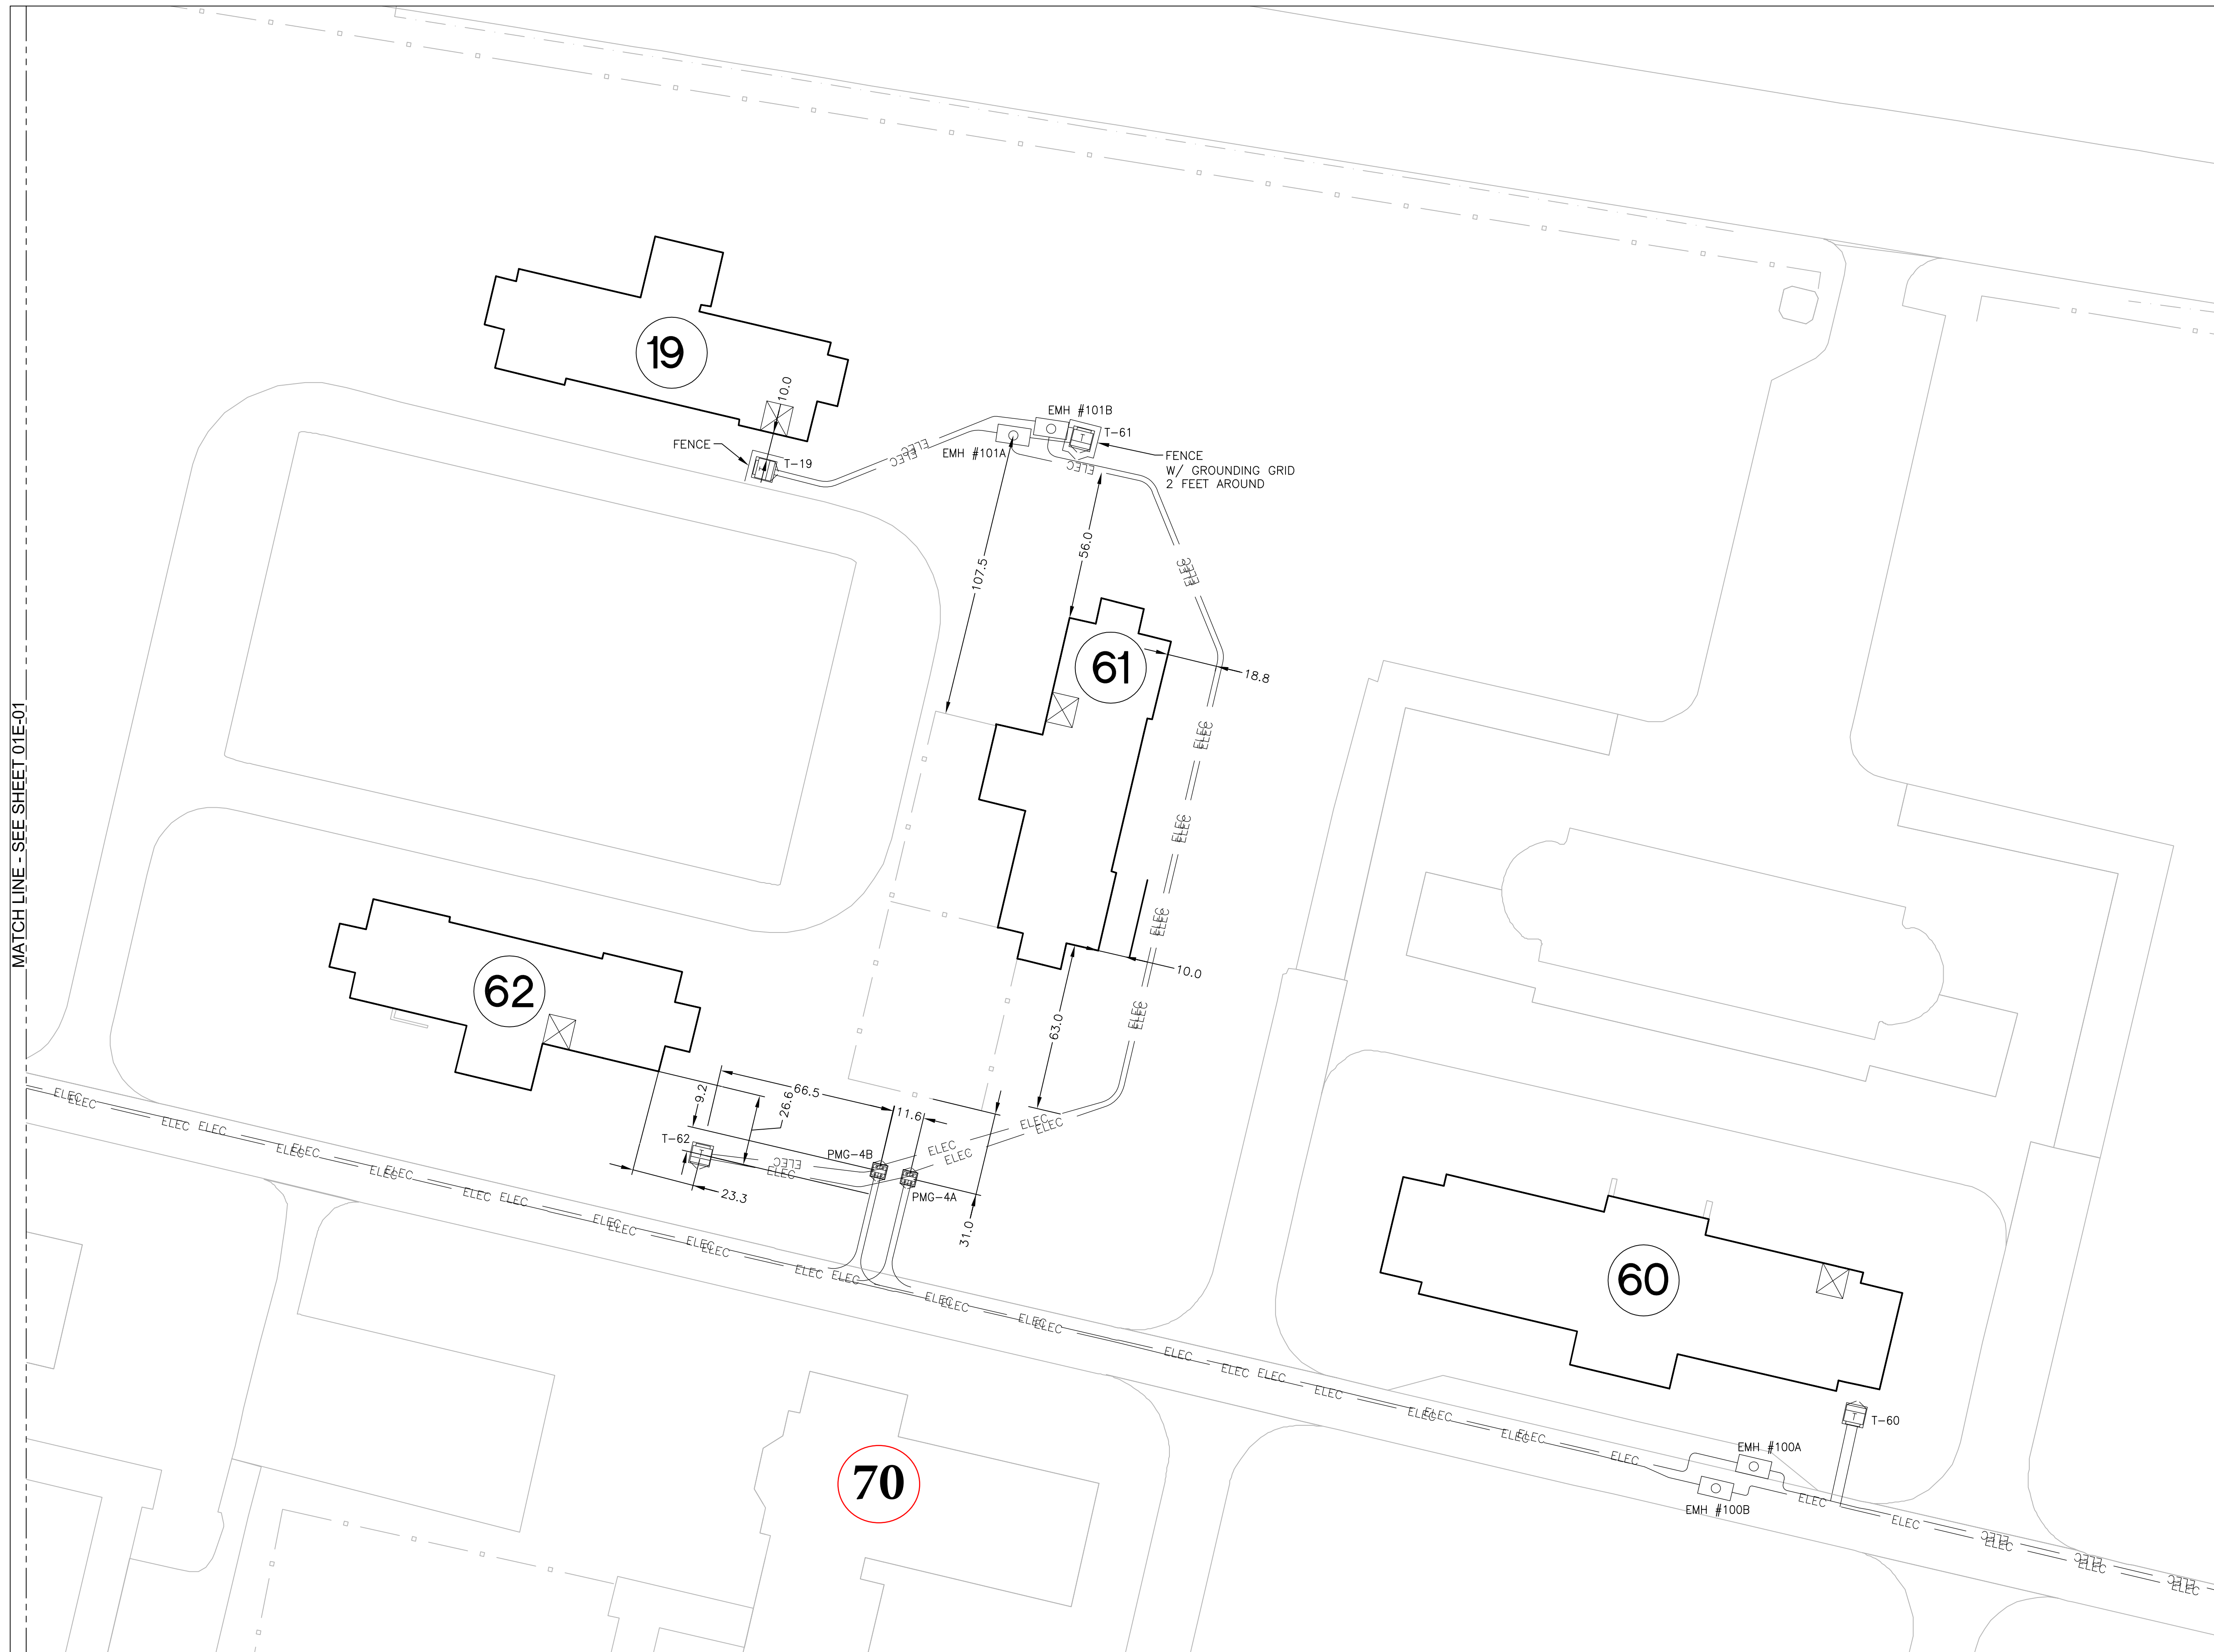

PROJECT RECORD
AS BUILT

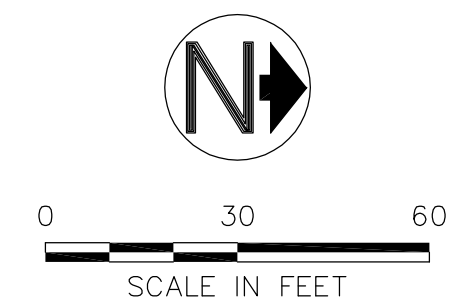



NEW YORK STATE
DEPARTMENT OF MENTAL HEALTH
CREEDMOOR PSYCHIATRIC CENTER
80-45 WINCHESTER BLVD
QUEENS, N.Y. 11427

ELECTRICAL SITE PLAN

01E-02

SCALE	1" = 30'
FILENAME	01E-01.dwg


- NOTES:
1. TYPICAL DEPTH OF DUCT BANK IS 42" A.F.G.
 2. NO UTILITIES WERE ENCOUNTERED DURING EXCAVATION UNLESS OTHERWISE NOTED.

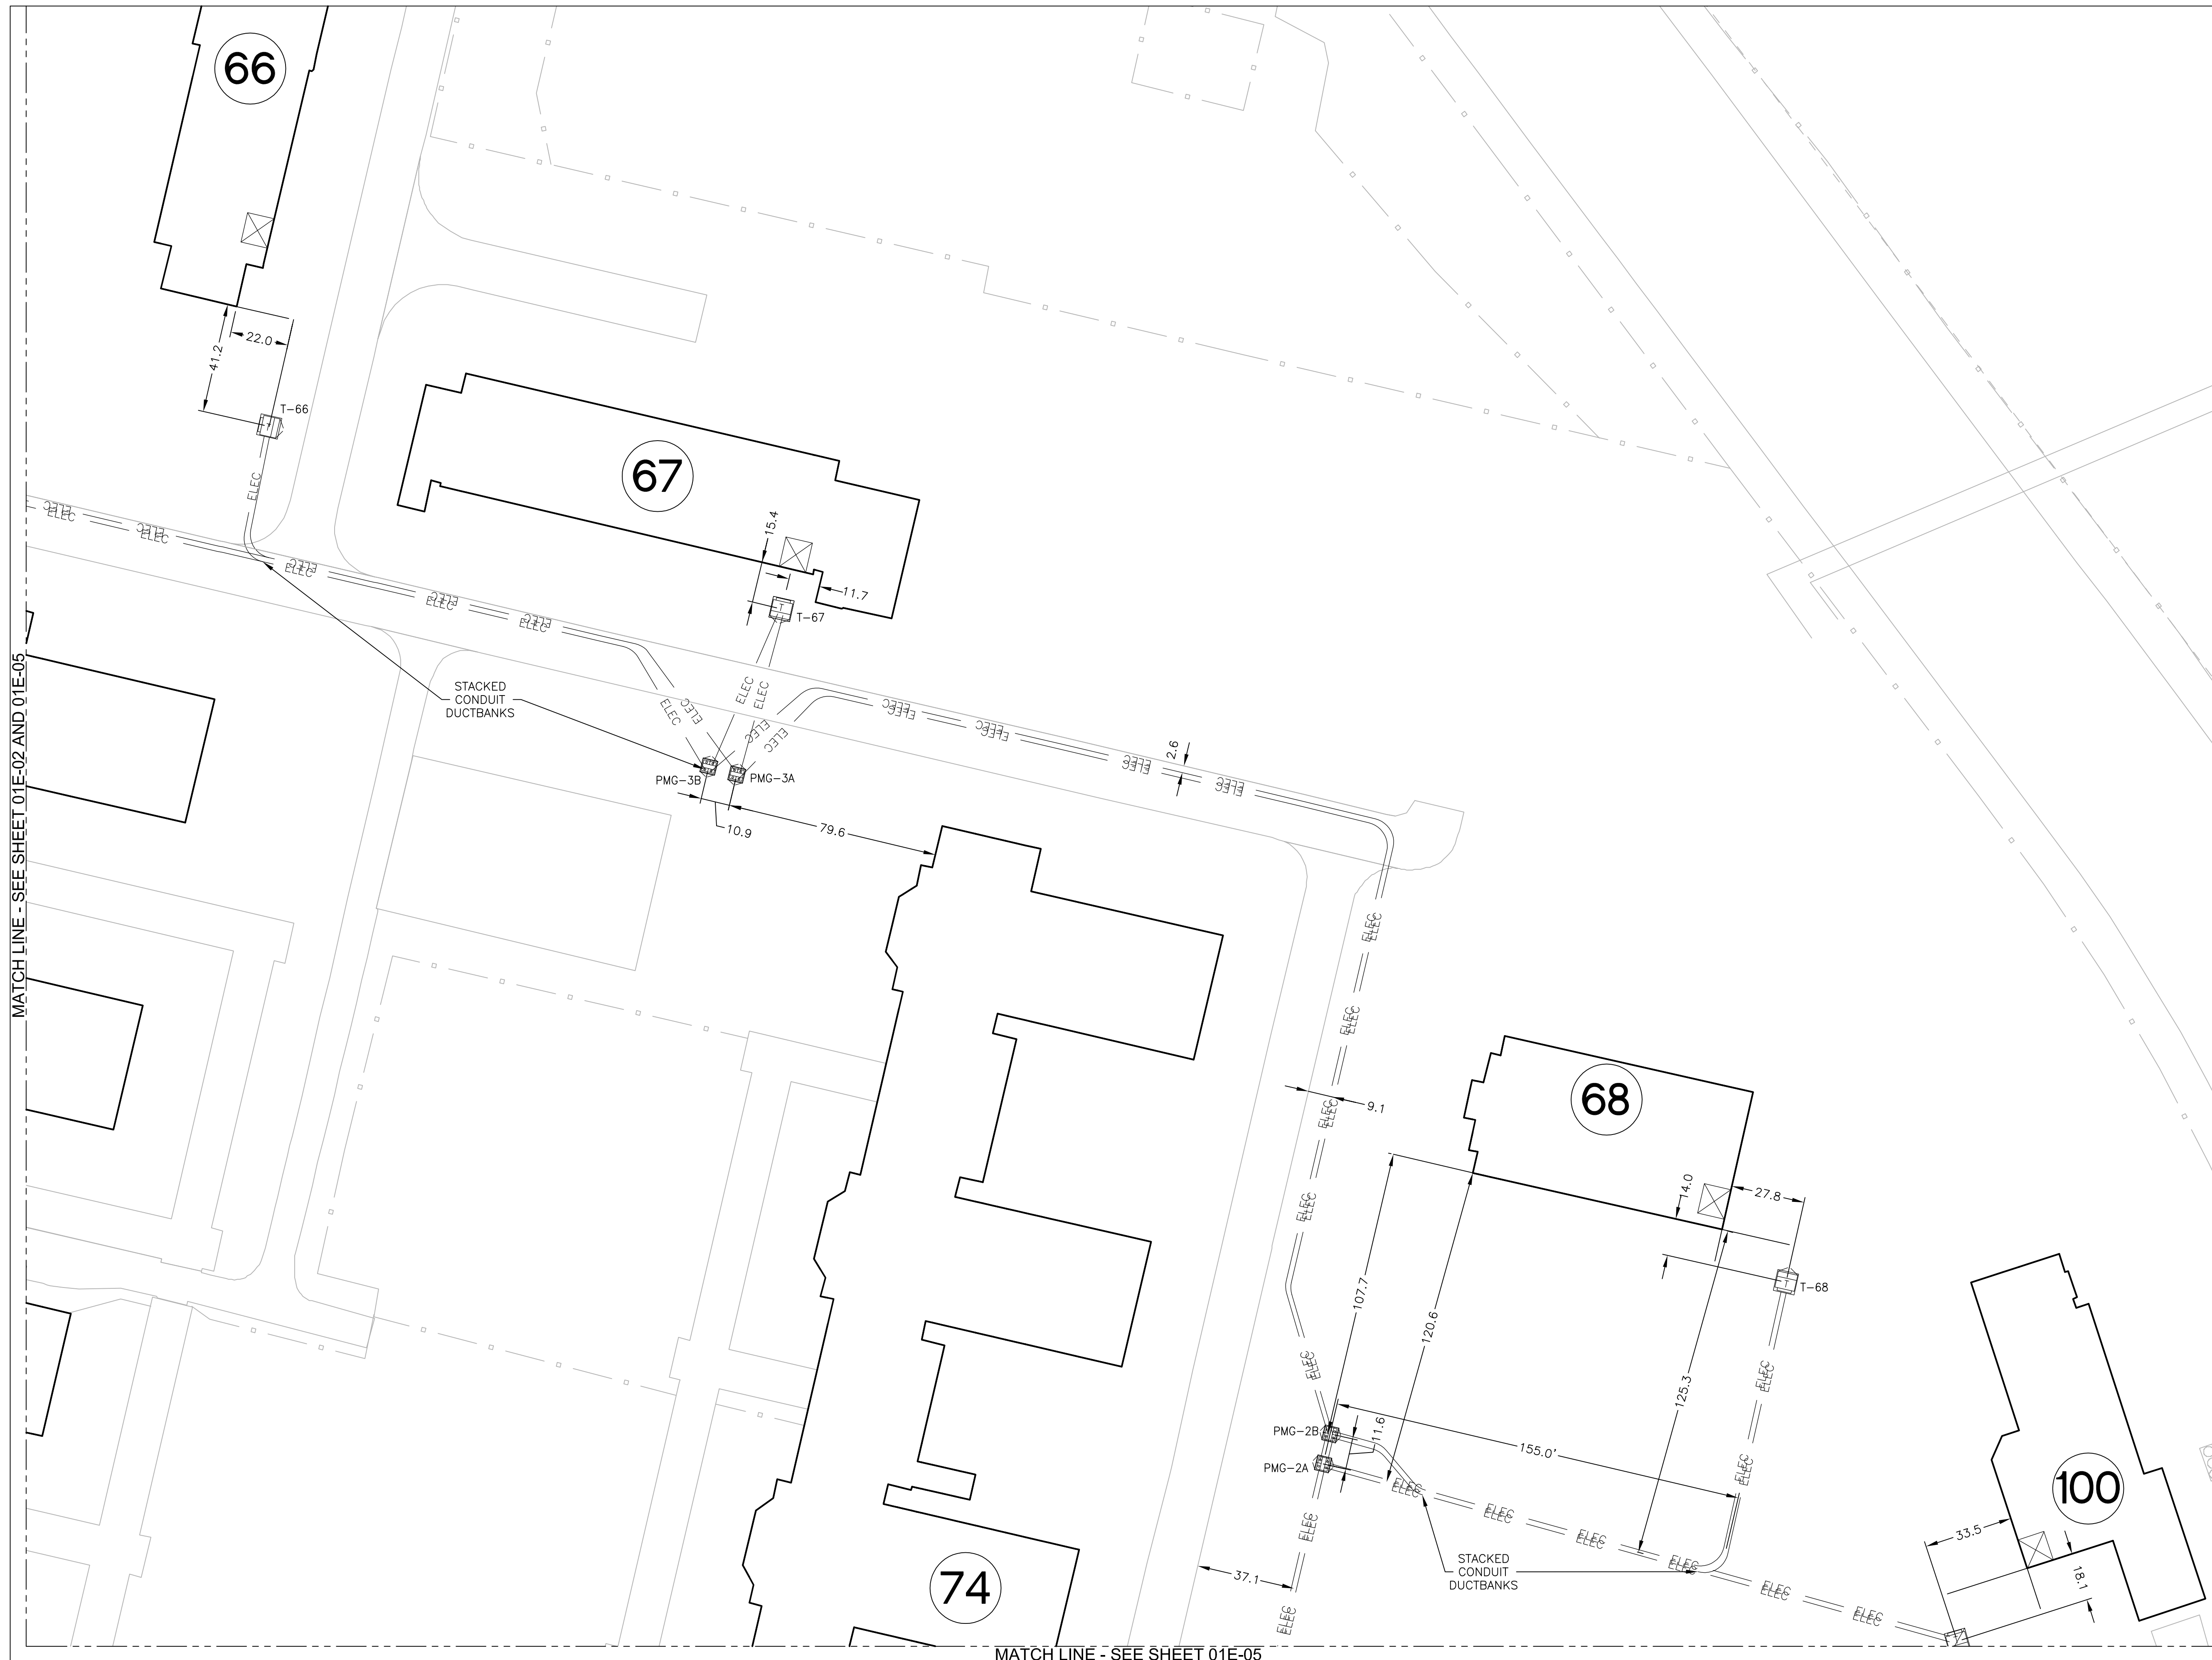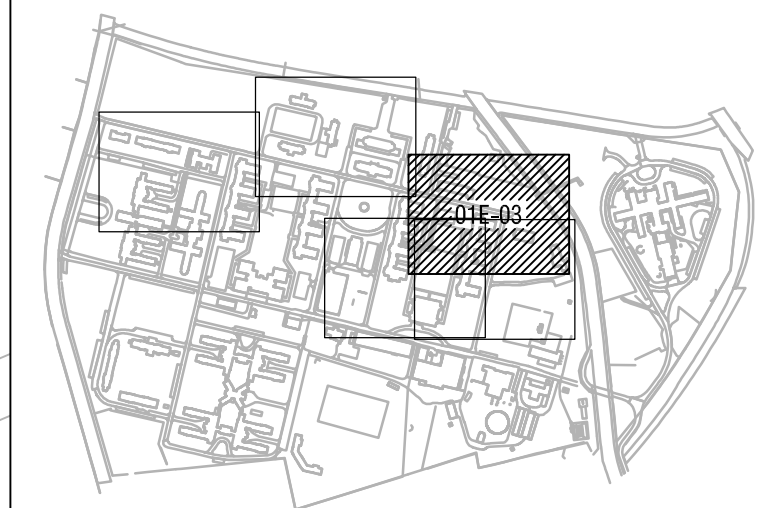

MATCH LINE - SEE SHEET 01E-02 AND 01E-05

MATCH LINE - SEE SHEET 01E-05

PROJECT RECORD AS BUILT

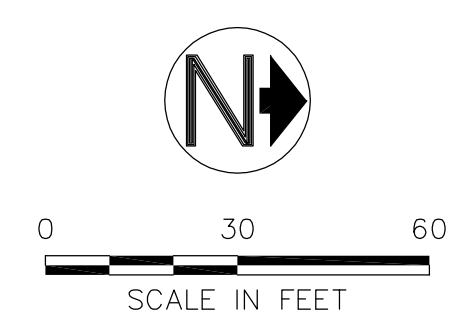

NEW YORK STATE
DEPARTMENT OF MENTAL HEALTH
CREEDMOOR PSYCHIATRIC CENTER
80-45 WINCHESTER BLVD
QUEENS, N.Y. 11427

ELECTRICAL SITE PLAN

01E-03

SCALE	1" = 30'
FILENAME	01E-01.dwg


MATCH LINE - SEE SHEET 01E-03



GLOBAL ELECTRICAL CONTRACTING
OF WESTCHESTER, INC.
985 NEPPERHAN AVENUE, YONKERS, NY 10710
PHONE (914) 958-1001
FAX (914) 958-5883

NOTES:


- 1. TYPICAL DEPTH OF DUCT BANK IS 42" A.F.G.
- 2. NO UTILITIES WERE ENCOUNTERED DURING EXCAVATION UNLESS OTHERWISE NOTED.

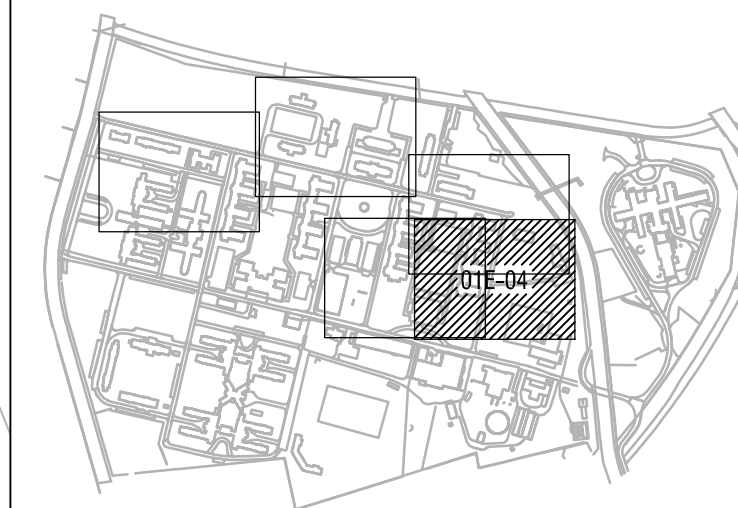

MATCH LINE - SEE SHEET 01E-05



PROJECT RECORD AS BUILT

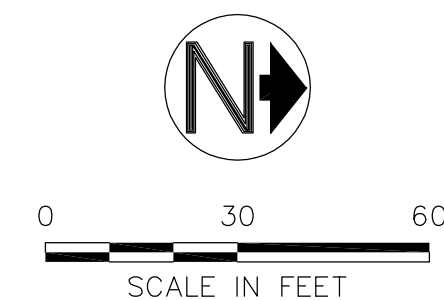

NEW YORK STATE
DEPARTMENT OF MENTAL HEALTH
CREEDMOOR PSYCHIATRIC CENTER
80-45 WINCHESTER BLVD
QUEENS, N.Y. 11427

ELECTRICAL SITE PLAN

01E-04

SCALE	1" = 30'
FILENAME	01E-01.dwg

- NOTES:
1. TYPICAL DEPTH OF DUCT BANK IS 42" A.F.G.
 2. NO UTILITIES WERE ENCOUNTERED DURING EXCAVATION UNLESS OTHERWISE NOTED.




MATCH LINE - SEE SHEET 01E-03

MATCH LINE - SEE SHEET 01E-04



PROJECT RECORD
AS BUILT

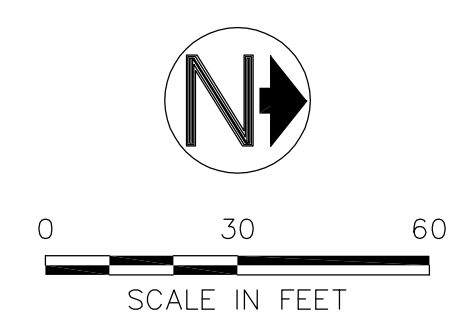

NEW YORK STATE
DEPARTMENT OF MENTAL HEALTH
CREEDMOOR PSYCHIATRIC CENTER
80-45 WINCHESTER BLVD
QUEENS, N.Y. 11427

ELECTRICAL SITE PLAN

01E-05

SCALE	1" = 30'
FILENAME	01E-01.dwg